

Appendix A- Main Lab Basement Underslab Piping Plans



- ALL PIPE SIZES AND LOCATIONS ARE APPROXIMATE. CONTRACTOR TO CAMERA INSPECT ALL UNDERSLAB PIPING AS ACCESSABILITY ALLOWS AND SHALL NOTE APPROXIMATE PIPE SIZING, MARK PIPE LOCATIONS ON SLAB, AND NOTE ANY FAILURES IN THE PIPE STRUCTURE.



**US Army Corps
of Engineers ®**

[illegible]

US ARMY CORPS OF ENGINEERS NEW ENGLAND DISTRICT 695 VIRGINIA RD CONCORD, MA	DESIGNED BY:	ISSUE DATE:
	DRAWN BY: M BOLDT	SOLICITATION NO.:
	CHECKED BY:	CONTRACT NO.:
	SUBMITTED BY:	
	SIZE:	ANSI/D

COLD REGIONS RESEARCH AND ENGINEERING LAB
DRAIN INVESTIGATION
HANOVER, NH

BASEMENT UNDERSLAB PLAN AREA 1

SHEET ID

P101U

Plot Date: 9/23/2024 8:17:19 AM
File Path: C:\Users\E8EDDMDB\Documents\CRREL_MIL_MEP_R21_E6EDDMOB.m

File Path:

9/23/2024 8:17:19 AM

Plot Date:





- ALL PIPE SIZES AND LOCATIONS ARE APPROXIMATE.
CONTRACTOR TO CAMERA INSPECT ALL UNDERSLAB PIPING
AS ACCESSABILITY ALLOWS AND SHALL NOTE APPROXIMATE
PIPE SIZING, MARK PIPE LOCATIONS ON SLAB, AND NOTE
ANY FAILURES IN THE PIPE STRUCTURE.



**US Army Corps
of Engineers®**

[illegible]

US ARMY CORPS OF ENGINEERS NEW ENGLAND DISTRICT 695 VIRGINIA RD CONCORD, MA	DESIGNED BY:	ISSUE DATE:
	DRAWN BY: M BOLDT	SOLICITATION NO.:
	CHECKED BY:	CONTRACT NO.:
	SUBMITTED BY:	
	SIZE:	ANSI/D


COLD REGIONS RESEARCH AND ENGINEERING LAB
DRAIN INVESTIGATION

BASEMENT UNDERSLAB PLAN - AREA 4

SHEET ID


P104U

Plot Date: 9/23/2024 8:17:22 AM
File Path: C:\Users\J\OneDrive\Documents\CRREL_ML_MEP_R21_E6EED\MOB.M

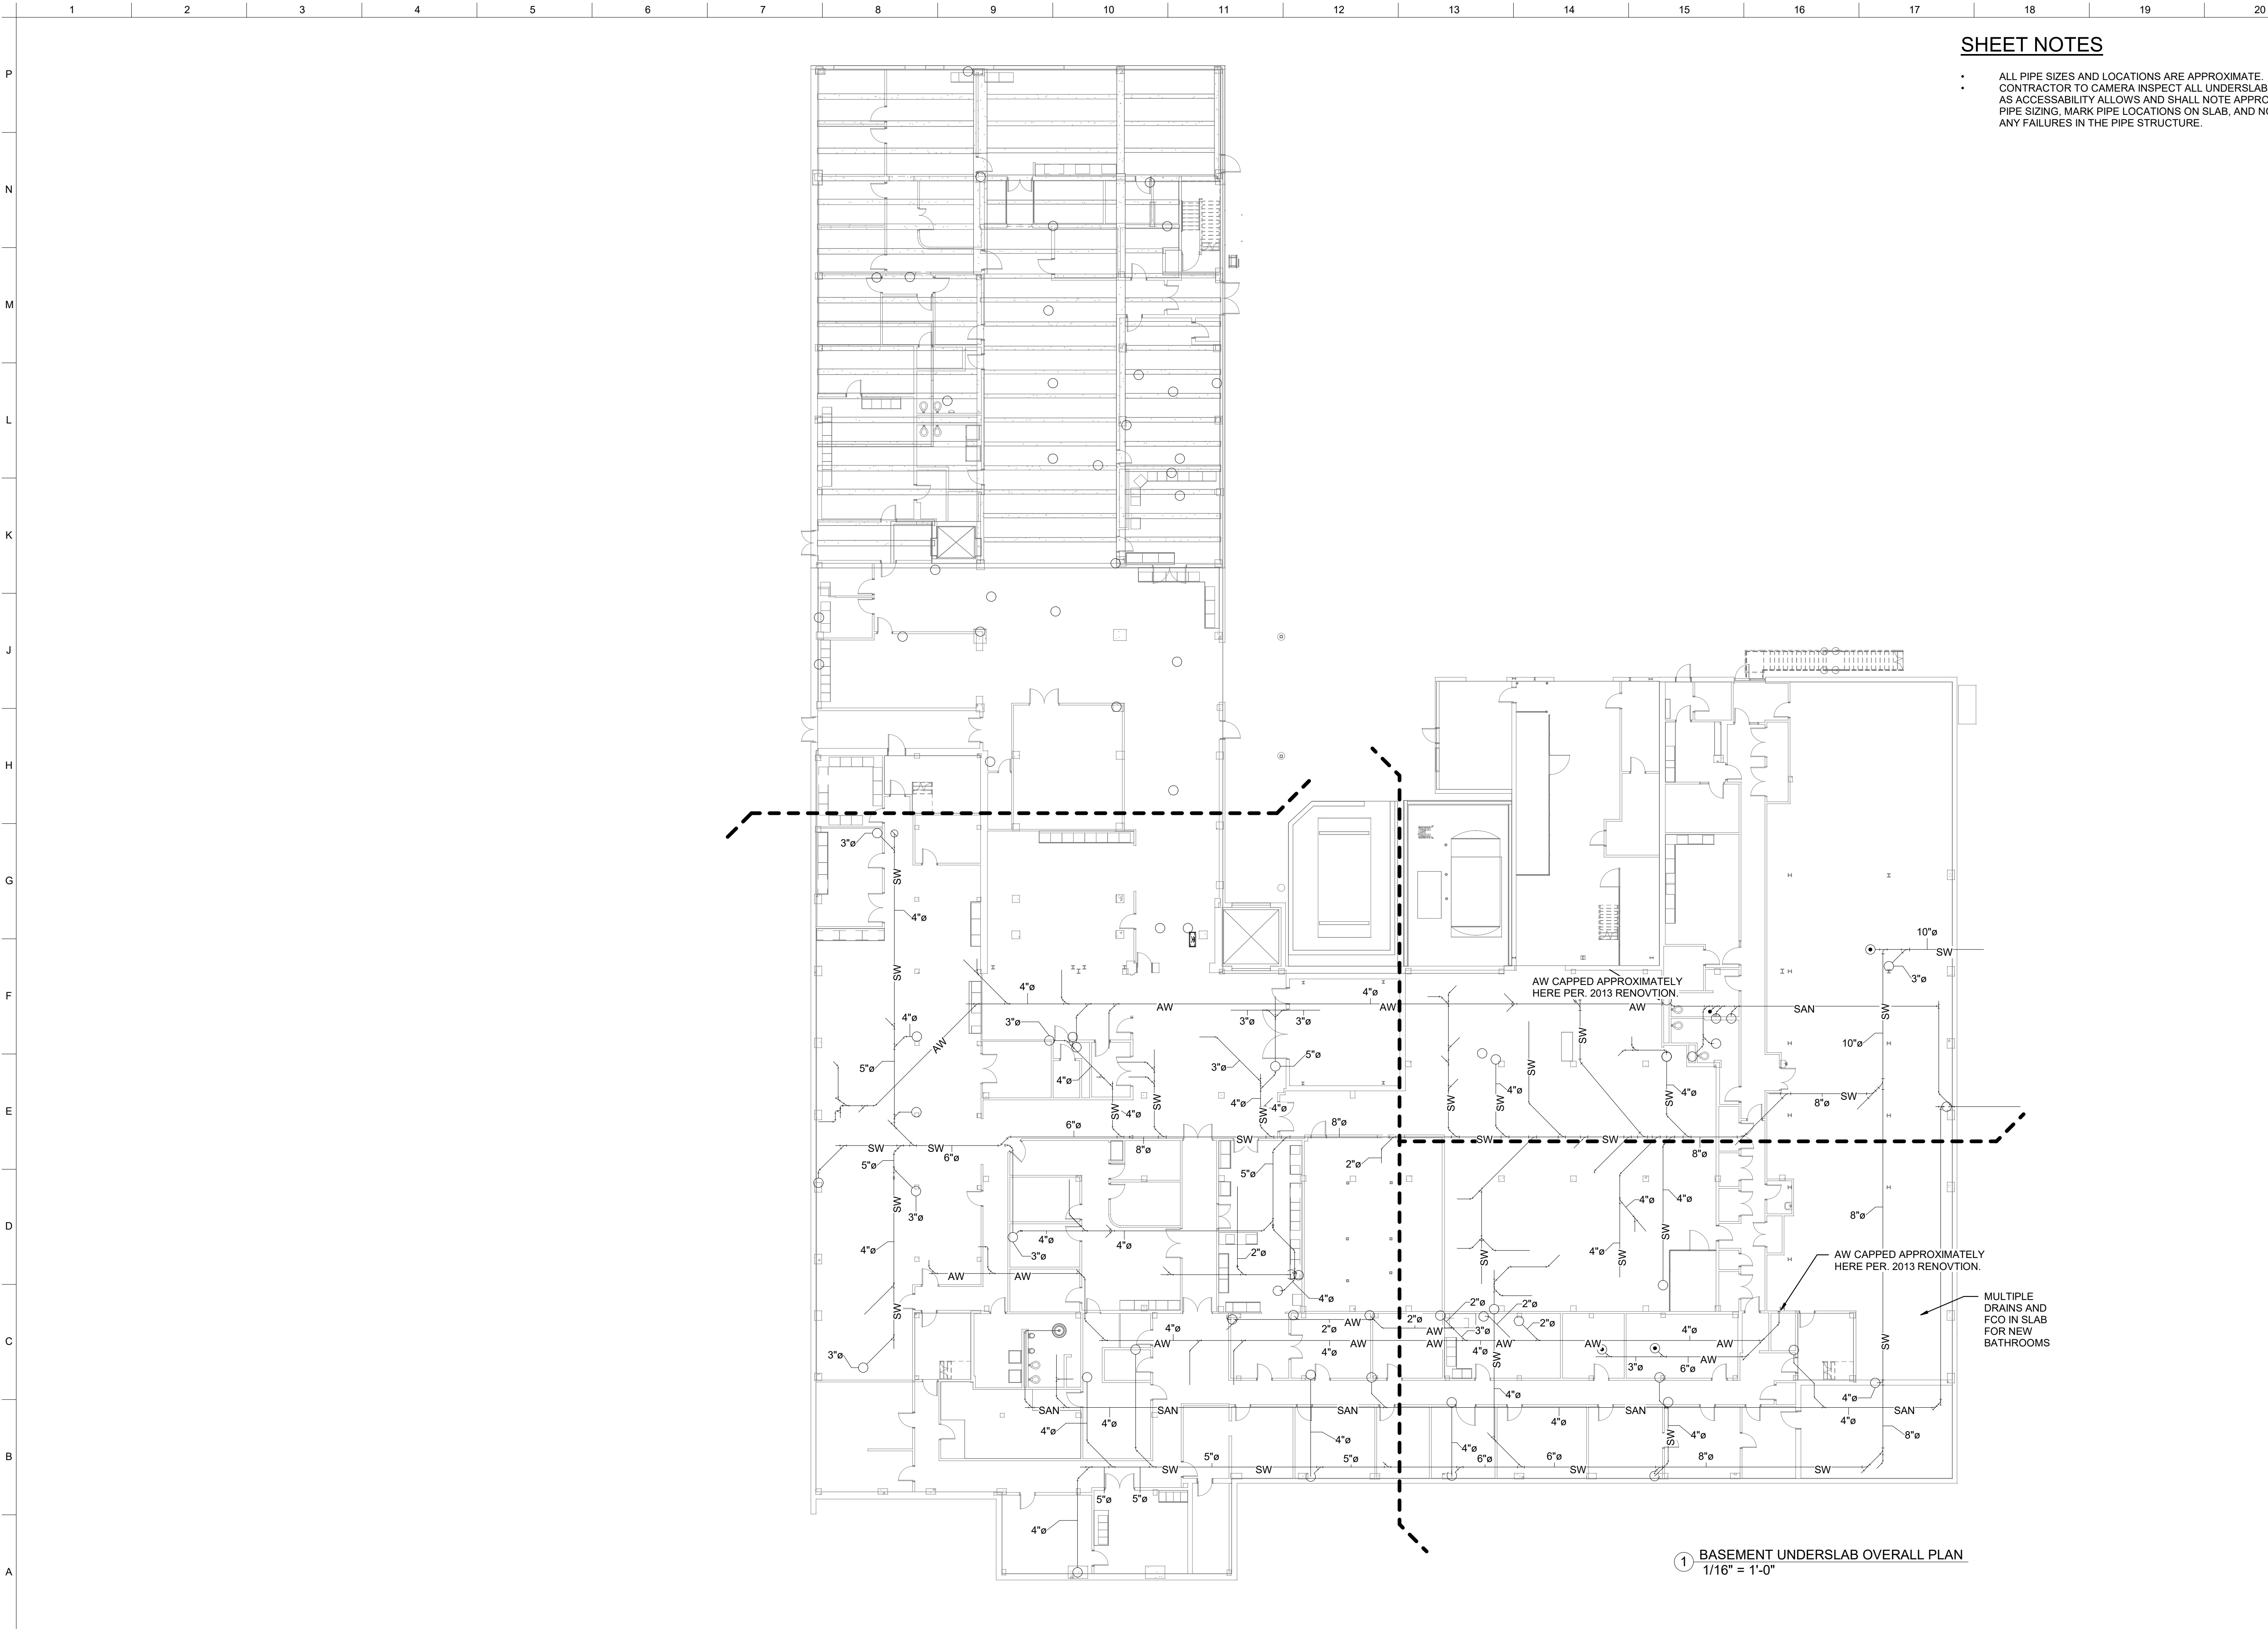

SHEET NOTES

- ALL PIPE SIZES AND LOCATIONS ARE APPROXIMATE. CONTRACTOR TO CAMERA INSPECT ALL UNDERSLAB PIPING AS ACCESSABILITY ALLOWS AND SHALL NOTE APPROXIMATE PIPE SIZING. MARK PIPE LOCATIONS ON SLAB, AND NOTE ANY FAILURES IN THE PIPE STRUCTURE.

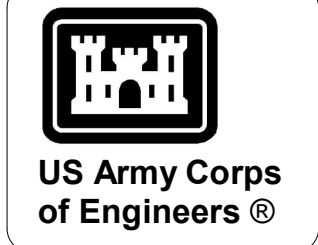

MARK	DESCRIPTION	DATE

US ARMY CORPS OF ENGINEERS NEW ENGLAND DISTRICT 696 VIRGINIA RD CONCORD, MA	DESIGNED BY:	ISSUE DATE:
	DRAWN BY: M. BOLDT	SOLICITATION NO.:
	CHECKED BY:	CONTRACT NO.:
	SUBMITTED BY:	
SIZE ANSI D		

COLD REGIONS RESEARCH AND ENGINEERING LAB DRAIN INVESTIGATION HANOVER, NH	BASEMENT UNDERSLAB OVERALL PLAN
---	---------------------------------

SHEET ID
PO100U

1 BASEMENT UNDERSLAB OVERALL PLAN
1/16" = 1'-0"