

INSTALL NEW WATER SERVICE AND CURB STOP - SEE DETAIL DRAWING C-503.


EXISTING WELL TO BE ABANDONED AFTER THE NEW WATER SERVICE IS INSTALLED AND IN USE

Approx. Location of Septic

NOTES:

1. CONTRACTOR TO CONFIRM LOCATION OF EXISTING SEPTIC SYSTEM AND AVOID AREA.
2. RESTORE LANDSCAPING TO ORIGINAL CONDITION.
3. EXISTING WATER SERVICE PIPE AND WELL PUMP POWER DUCT TO BE CUT AND CAPPED WATERTIGHT AT WELL AND BUILDING INTERIOR AND ABANDONED IN PLACE.
4. REMOVE AND DISPOSE OF EXISTING SUBMERSIBLE WELL PUMP FROM WELL UNLESS OTHERWISE DIRECTED.

EPA CONTRACT NO. EP-S1-06-01 DURHAM MEADOWS WATERLINE RD DURHAM AND MIDDLETOWN, CONNECTICUT TASK ORDER NO. 0060-RD-RD-01D5		TOWN OF DURHAM 110 MAPLE AVE. SITE PLAN	
REV 1	12/12/19	MC	MC
MARK	DATE	MADE BY	CHECKED
PROJECT NO: 60275749		CAD FILE: SER-DUR-110MAPLE.dwg	
DESIGNED BY: MC		DRAWN BY: MC	
DATE: APRIL 2018		SCALE: 1" = 40'	
SHEET 1 OF 4		AECOM AECOM, INC. 500 ENTERPRISE DRIVE ROCKY HILL, CT 06067 PHONE (860) 263-5800	


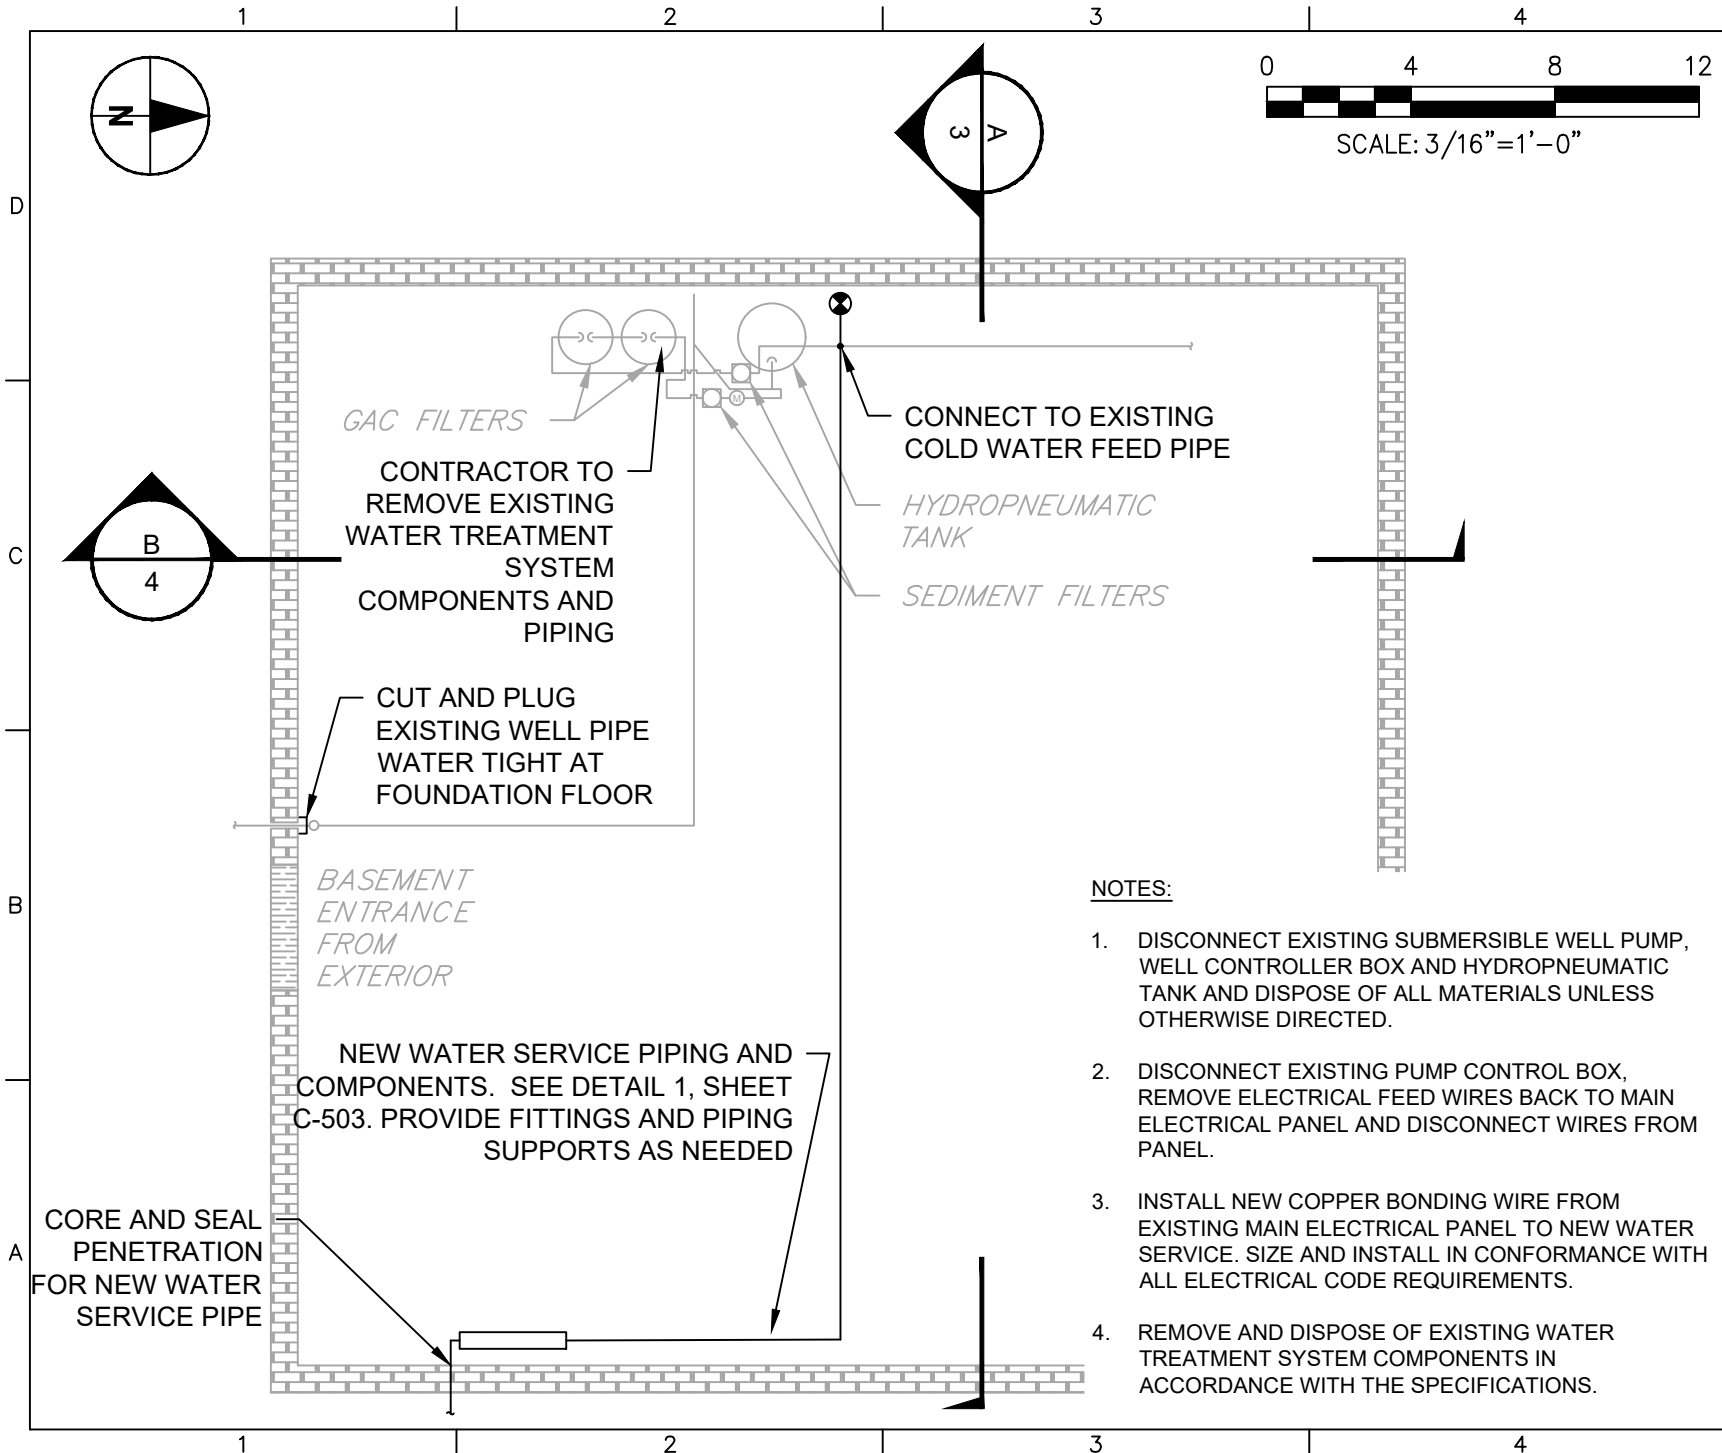


NOTES:

1. DISCONNECT EXISTING SUBMERSIBLE WELL PUMP, WELL CONTROLLER BOX AND HYDROPNEUMATIC TANK AND DISPOSE OF ALL MATERIALS UNLESS OTHERWISE DIRECTED.
2. DISCONNECT EXISTING PUMP CONTROL BOX, REMOVE ELECTRICAL FEED WIRES BACK TO MAIN ELECTRICAL PANEL AND DISCONNECT WIRES FROM PANEL.
3. INSTALL NEW COPPER BONDING WIRE FROM EXISTING MAIN ELECTRICAL PANEL TO NEW WATER SERVICE. SIZE AND INSTALL IN CONFORMANCE WITH ALL ELECTRICAL CODE REQUIREMENTS.
4. REMOVE AND DISPOSE OF EXISTING WATER TREATMENT SYSTEM COMPONENTS IN ACCORDANCE WITH THE SPECIFICATIONS.

EPA CONTRACT NO. EP-S1-06-01 DURHAM MEADOWS WATERLINE RD DURHAM AND MIDDLETOWN, CONNECTICUT TASK ORDER NO. 0060-RD-RD-01D5		TOWN OF DURHAM 110 MAPLE AVE. INTERIOR SERVICE CONNECTIONS PLAN VIEW		AECOM, INC. 500 ENTERPRISE DRIVE ROCKY HILL, CT 06067 PHONE (860) 263-5800	
REV 1	MARK	12/12/19	DATE	MC	MADE BY CHECKED
				MC	
					DESCRIPTION
					REVISIONS
PROJECT NO: 60275749					
CAD FILE: 110 Maple Ave.dwg					
DESIGNED BY: JT					
DRAWN BY: JT					
DATE: APRIL 2018					
SCALE: 3/16" = 1' - 0"					
SHEET 2 OF 4					


SOUTH VIEW

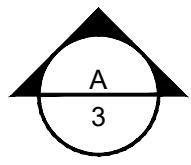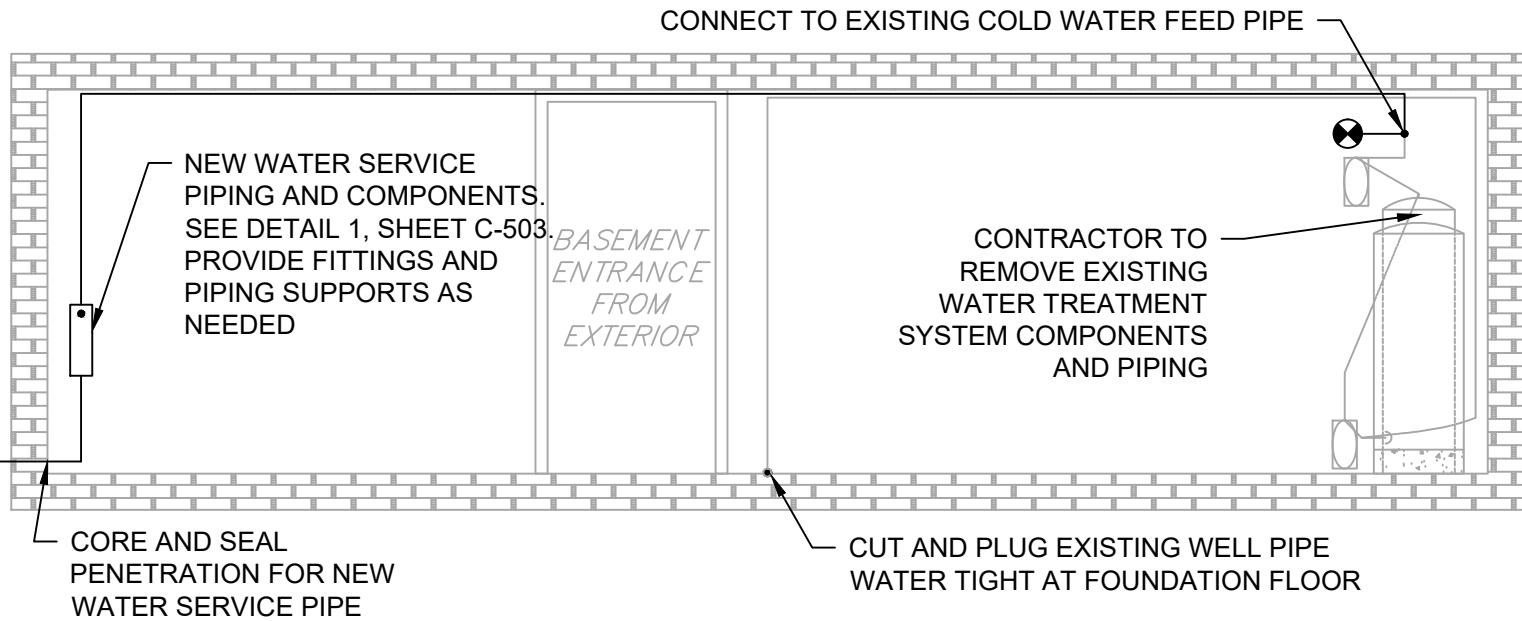


SECTION A-A

EPA CONTRACT NO. EP-S1-06-01 DURHAM MEADOWS WATERLINE RD DURHAM AND MIDDLETOWN, CONNECTICUT TASK ORDER NO. 0060-RD-RD-01D5		REV 1	12/12/19	MC	MC	AECOM, INC. 500 ENTERPRISE DRIVE ROCKY HILL, CT 06067 PHONE (860) 263-5800	
TOWN OF DURHAM 110 MAPLE AVE. INTERIOR SERVICE CONNECTIONS ELEVATION VIEW		MARK	DATE	MADE BY	CHECKED	DESCRIPTION	REVISIONS
PROJECT NO: 60275749		CAD FILE: 110 Maple Ave.dwg		DESIGNED BY: JT		DRAWN BY: JT	
DATE: APRIL 2018		SCALE: 1/4" = 1' - 0"		SHEET 3 OF 4			

 WEST VIEW



SCALE: 1/4" = 1'-0"

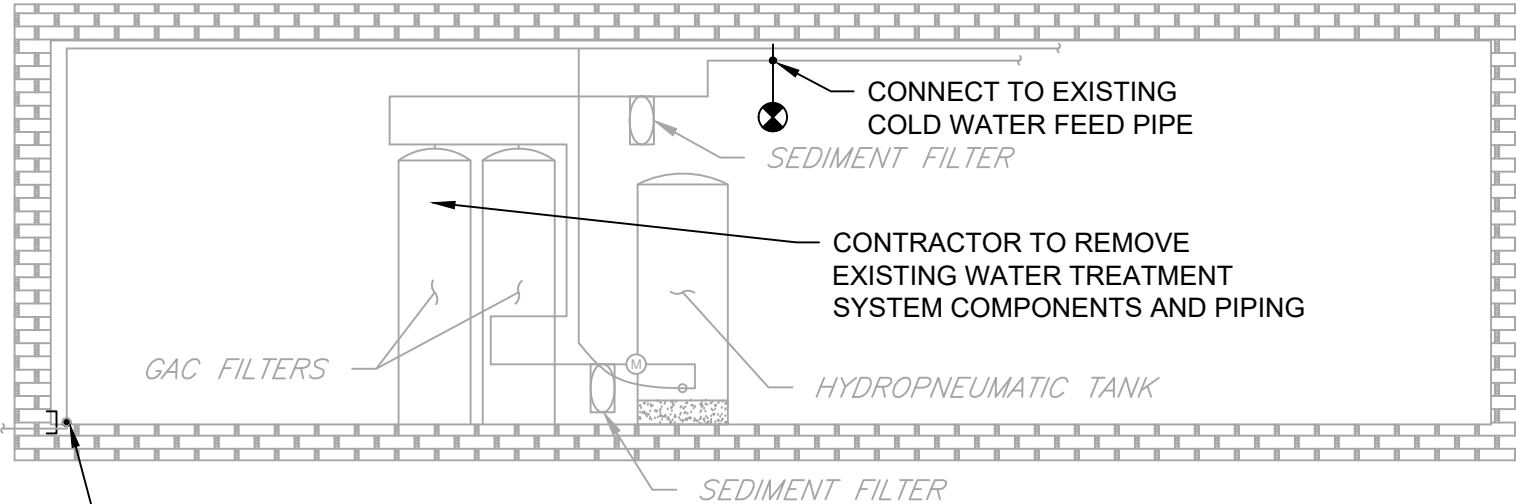

CUT AND PLUG EXISTING WELL PIPE
WATER TIGHT AT FOUNDATION FLOOR


CONNECT TO EXISTING
COLD WATER FEED PIPE
SEDIMENT FILTER

CONTRACTOR TO REMOVE
EXISTING WATER TREATMENT
SYSTEM COMPONENTS AND PIPING

GAC FILTERS

HYDROPNEUMATIC TANK

SEDIMENT FILTER

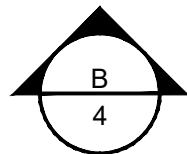

SECTION B-B

EPA CONTRACT NO. EP-S1-06-01 DURHAM MEADOWS WATERLINE RD DURHAM AND MIDDLETOWN, CONNECTICUT TASK ORDER NO. 0060-RD-RD-01D5		REV 1	12/12/19	MC	MC	AECOM, INC. 500 ENTERPRISE DRIVE ROCKY HILL, CT 06067 PHONE (860) 263-5800	
TOWN OF DURHAM 110 MAPLE AVE. INTERIOR SERVICE CONNECTIONS ELEVATION VIEW		MARK	DATE	MADE BY	CHECKED	DESCRIPTION	REVISIONS
PROJECT NO: 60275749							
CAD FILE: 110 Maple Ave.dwg							
DESIGNED BY: JT							
DRAWN BY: JT							
DATE: APRIL 2018							
SCALE: 1/4" = 1' - 0"							
SHEET 4 OF 4							