


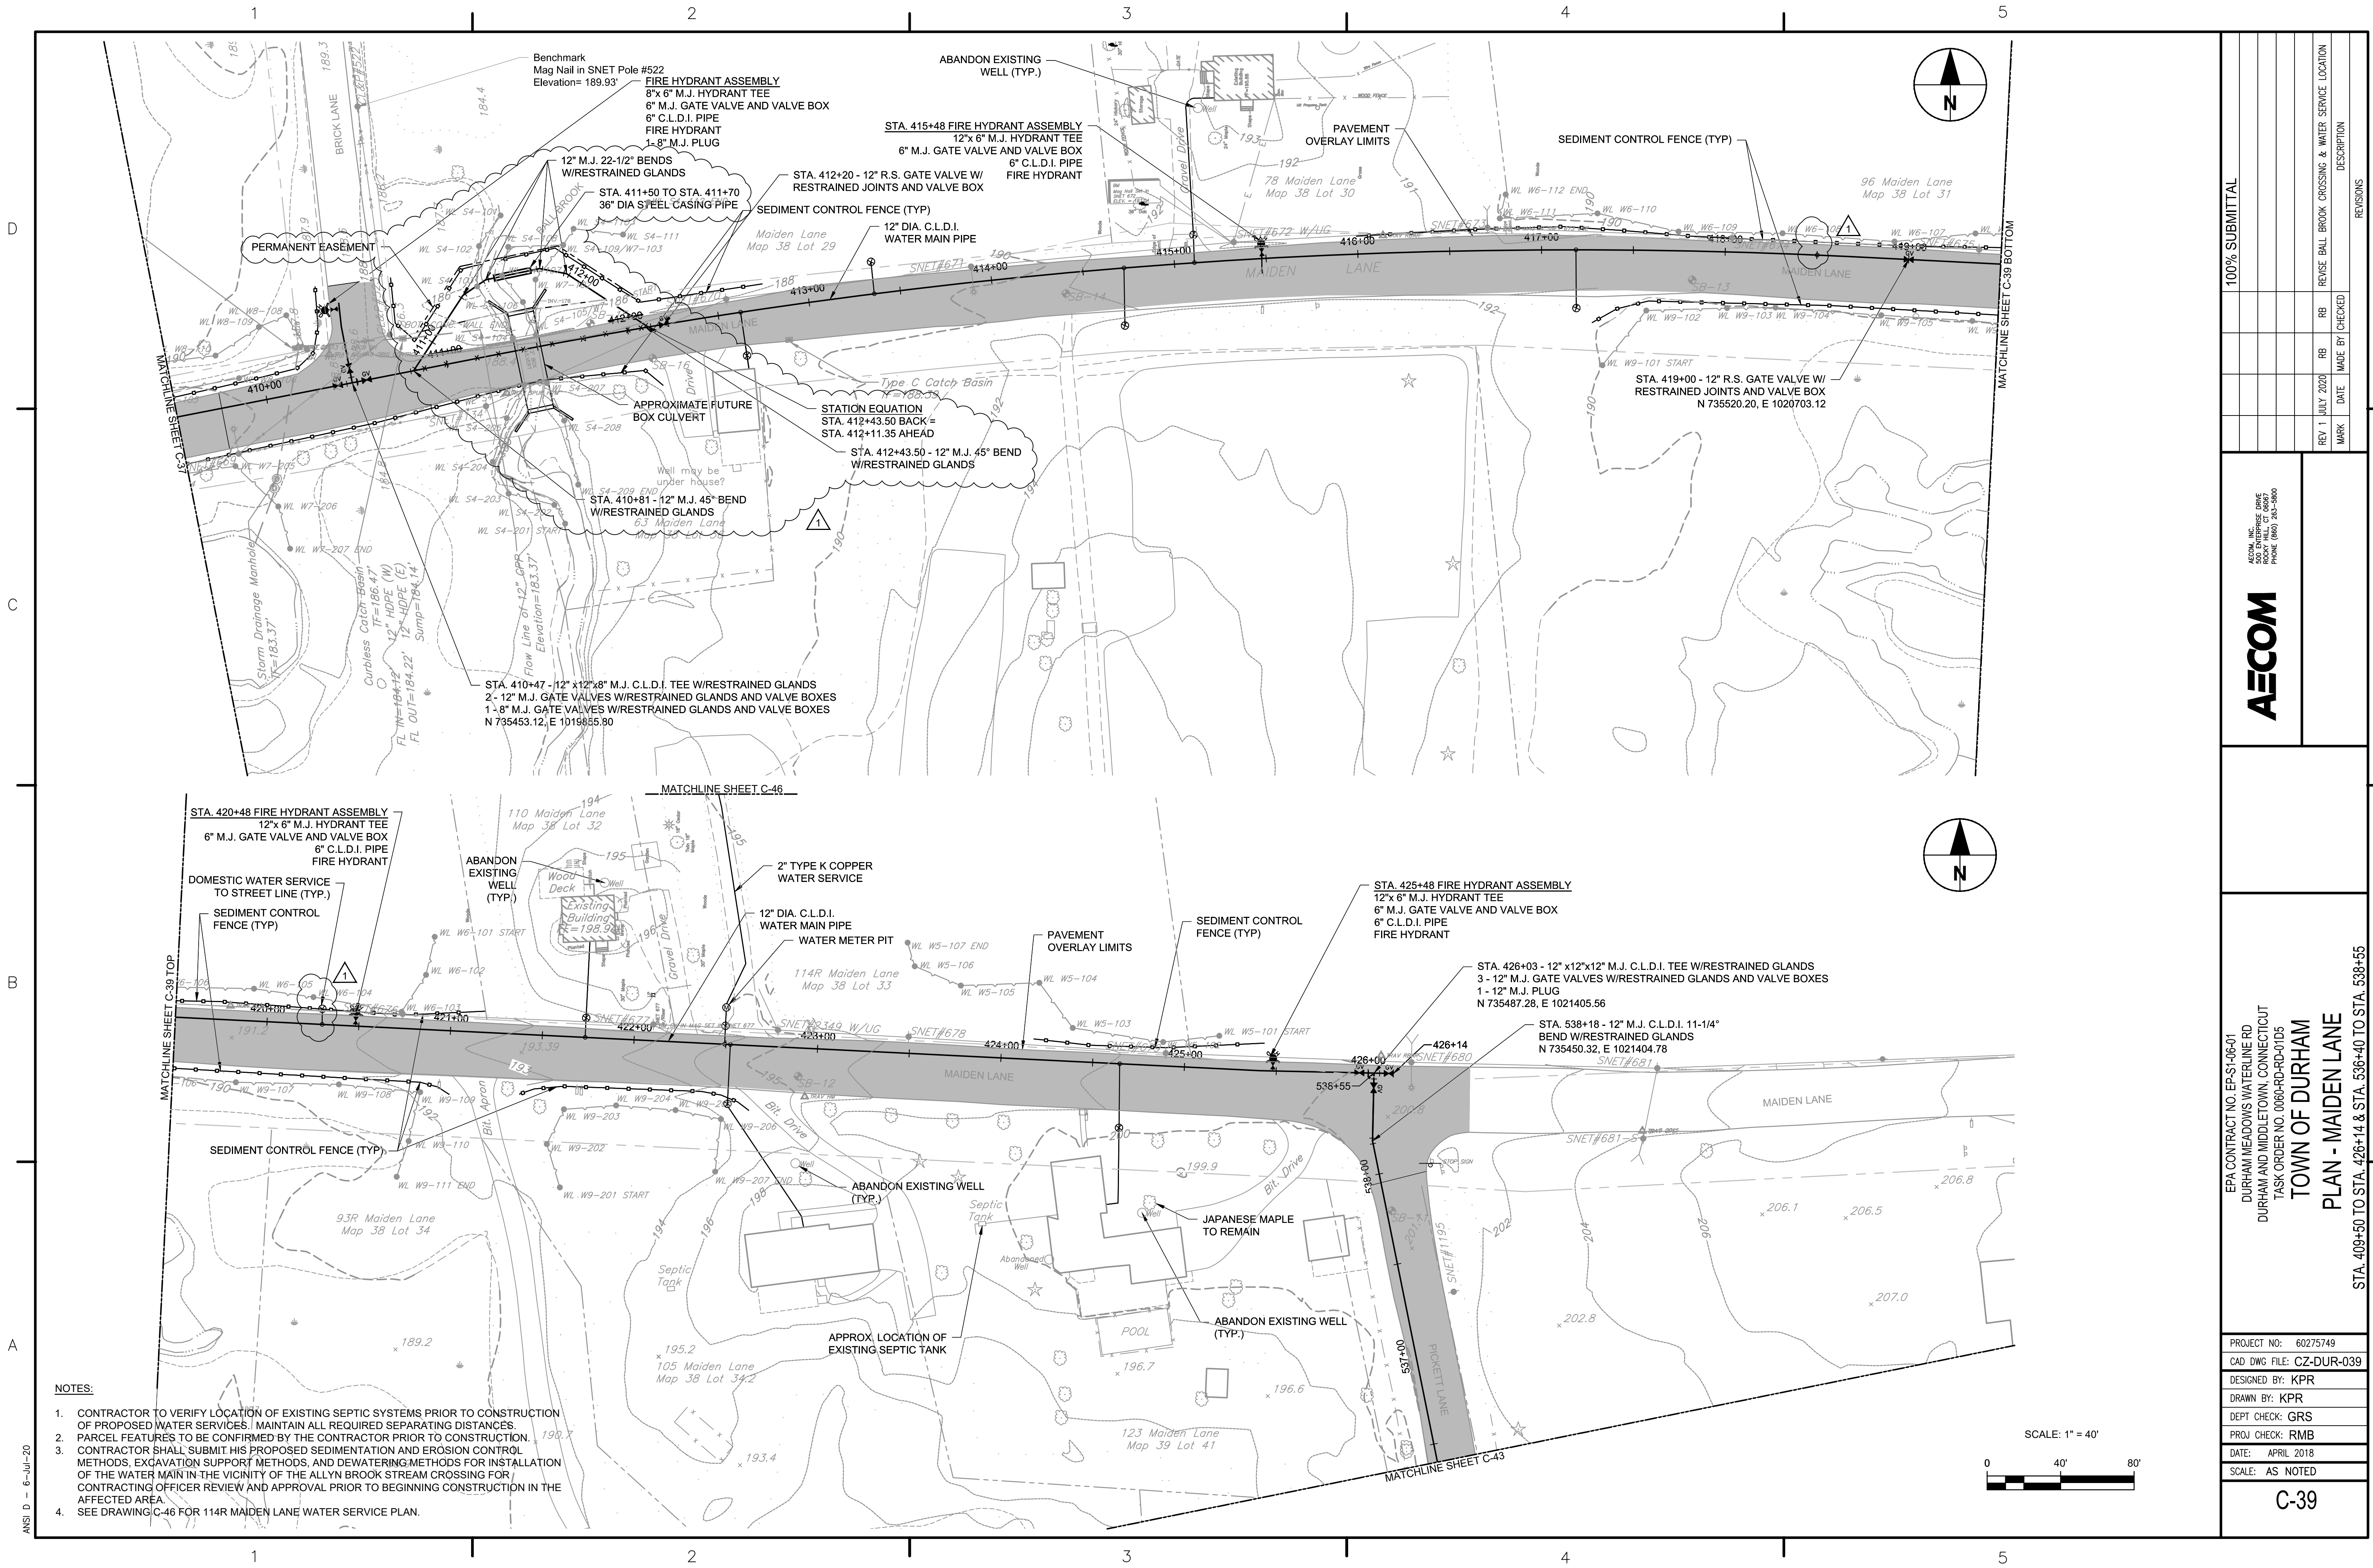

- NOTES:
1. CONTRACTOR TO VERIFY LOCATION OF EXISTING SEPTIC SYSTEMS PRIOR TO CONSTRUCTION OF PROPOSED WATER SERVICES. MAINTAIN ALL REQUIRED SEPARATING DISTANCES.
 2. PARCEL FEATURES TO BE CONFIRMED BY THE CONTRACTOR PRIOR TO CONSTRUCTION.
 3. CONTRACTOR SHALL SUBMIT HIS PROPOSED SEDIMENTATION AND EROSION CONTROL METHODS, EXCAVATION SUPPORT METHODS, AND DEWATERING METHODS FOR INSTALLATION OF THE WATER MAIN IN THE VICINITY OF THE ALLYN BROOK STREAM CROSSING FOR CONTRACTING OFFICER REVIEW AND APPROVAL PRIOR TO BEGINNING CONSTRUCTION IN THE AFFECTED AREA.
 4. SEE DRAWING C-46 FOR 114R MAIDEN LANE WATER SERVICE PLAN.

100% SUBMITTAL

REV 1 JULY 2020

MARK

DATE

MADE BY

CHECKED

REVISIONS

DESCRIPTION

REVISE BALL BROOK CROSSING & WATER SERVICE LOCATION

PROJECT NO: 60275749

CAD DWG FILE: CZ-DUR-039

DESIGNED BY: KPR

DRAWN BY: KPR

DEPT CHECK: GRS

PROJ CHECK: RMB

DATE: APRIL 2018

SCALE: AS NOTED

C-39

EPA CONTRACT NO. EP-SI-06-01

DURHAM MEADOWS WATERLINE RD

DURHAM AND MIDDLETOWN, CONNECTICUT

TASK ORDER NO. 006A-RD-0105

TOWN OF DURHAM

PLAN - MAIDEN LANE

STA. 409+50 TO STA. 426+14 & STA. 536+40 TO STA. 538+55

AECOM

AECOM, INC.
200 PARKWAY DRIVE
ROSELAND, NJ 07068
PHONE (860) 263-1900